


File Name: P:\2019\191148_Yarralumla-Brickworks\04_CAD\4.2_Drawings\CIV\EDP\191148-drg-civ-34-00.dwg

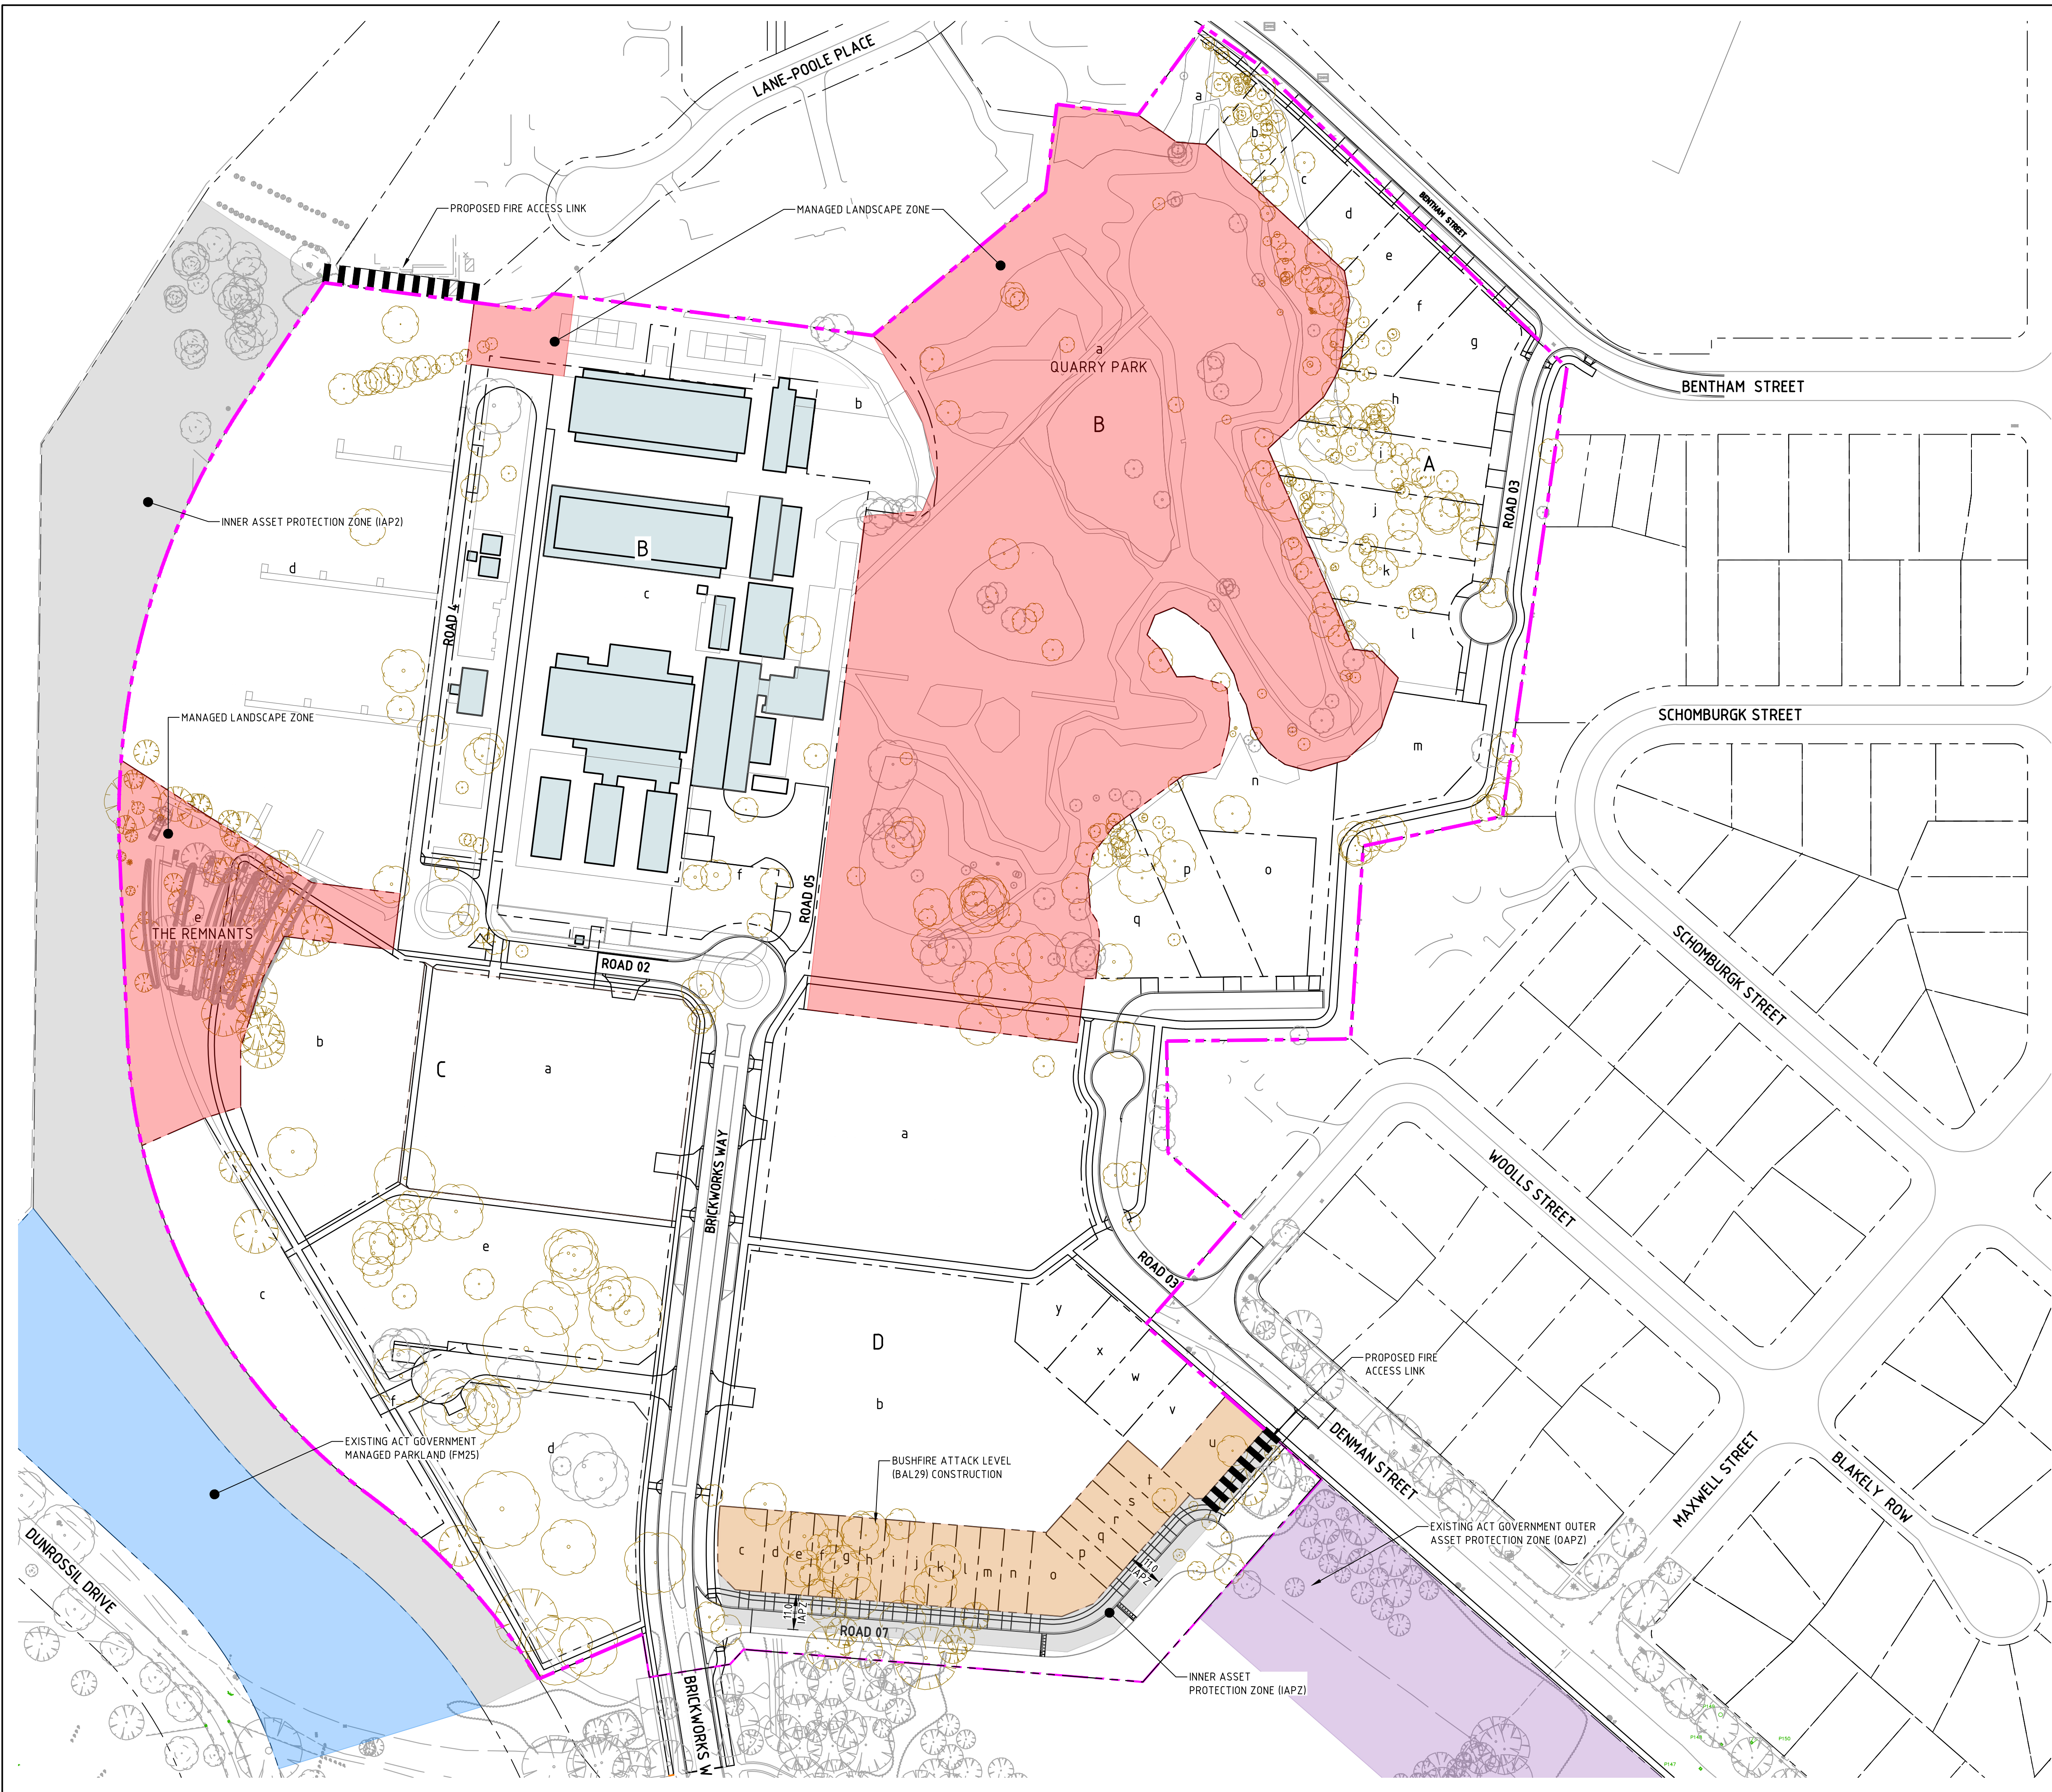

Status

NOT FOR CONSTRUCTION

DO NOT SCALE OFF DRAWINGS. VERIFY ALL DIMENSIONS ON SITE PRIOR TO WORK.
 COPYRIGHT: The contents and information contained in this document are copyright of Sellick Consultants. Use or copy of this document in whole or part without written permission constitutes an infringement of copyright.

Rev	Description	Date	Drawn By
F	EDP SUBMISSION	31.07.2023	MN
E	EDP SUBMISSION	10.07.2023	MN
D	EDP SUBMISSION	22.06.2023	RT
C	EDP SUBMISSION	21.06.2023	RT
B	EDP SUBMISSION	20.06.2023	RT
A	EDP SUBMISSION	16.06.2023	RT

LEGEND

- HOLDING LEASE BOUNDARY
- PROPOSED BLOCK BOUNDARY
- EXISTING TREE TO BE REMOVED
- EXISTING TREE TO BE RETAINED
- PROPOSED CONTOUR
- EXISTING CONTOUR
- PROPOSED FIRE ACCESS LINK
- MANAGED LANDSCAPE ZONE
- INNER ASSET PROTECTION ZONE (IAPZ)
- EXISTING ACT GOVERNMENT MANAGED PARKLAND
- EXISTING ACT GOVERNMENT OUTER ASSET PROTECTION ZONE (OAPZ)
- BUSHFIRE ATTACK LEVEL (BAL29) 29kW/m² CONSTRUCTION

- ZONES PROVIDED BY AUSTRALIAN BUSHFIRE PROTECTION PLANNERS PTY LTD
- THIS PLAN HAS BEEN REVIEWED AND ENDORSED BY AUSTRALIAN BUSHFIRE PROTECTION PLANNERS PTY LTD

Scales

0 20 30 40 50m
1:1000 @ A1

canberra | sydney
ABN 82 634 296 629

Client Logo

DOMA

Original Size	A1	Drawn By	DA	Drafting Check	DCA
Date Plotted	31-Jul-23	Designed By	AE	Design Check	BC
Coordinate System	STROMLO GRID	Approved	BC	Approved Date	16/12/2019
Height Datum	AHD	Approved Signature			

Project Name and Location

THE CANBERRA BRICKWORKS
BLOCKS 1,7 & 20 SECTION 102

Drawing Title

EDP - BUSHFIRE MANAGEMENT PLAN

Project Number	Type	Discipline	Drg No.	Sub-No.	Rev
191148	DRG	CIV	34	00	F