



NOTES

1. FOR LEGEND AND SYMBOLS REFER TO DRAWING E001.
2. ALL WORKS TO BE DONE IN ACCORDANCE TO AS/NZS 3000.
3. THIS DRAWING TO BE READ IN CONJUNCTION WITH ALL OTHER ELECTRICAL DRAWINGS AND THE SPECIFICATION.
4. COORDINATE FINAL LOCATIONS OF ALL LUMINAIRES AND CONTROLS WITH OTHER SERVICES ON SITE TO MECHANICAL, FIRE, HYDRAULICS AND ARCHITECTURAL SERVICES DRAWINGS AS NECESSARY.
5. PROVIDE LUMINAIRES AND ASSOCIATED FINAL SUB-CIRCUIT WIRING AS REQUIRED TO COMPLETE THE INSTALLATION.
6. PROVIDE COMBINED MCB AND 30MA RCD IN DISTRIBUTION BOARD FOR LIGHTING SUB-CIRCUITS OF 20A OR LESS. BALANCE THE LOAD EQUALLY ACROSS ALL THREE PHASES.
7. INTERNAL LUMINAIRES TO BE CONTROLLED BY LOCAL LIGHT SWITCHES, SENSORS AND TIME CLOCK IN ACCORDANCE WITH THE BCA.
8. CONNECT ALL EMERGENCY FITTINGS TO THE MANUAL DISCHARGE TEST FACILITY AT EACH DISTRIBUTION BOARD.
9. EXTERNAL LIGHTS TO BE CONTROLLED BY PE CELL AND TIMECLOCK CW AUTOMANUAL SWITCH LOCATED IN THE RELEVANT DISTRIBUTION BOARD.
10. LIGHTING FOR STORAGE UNDER STAIRS.

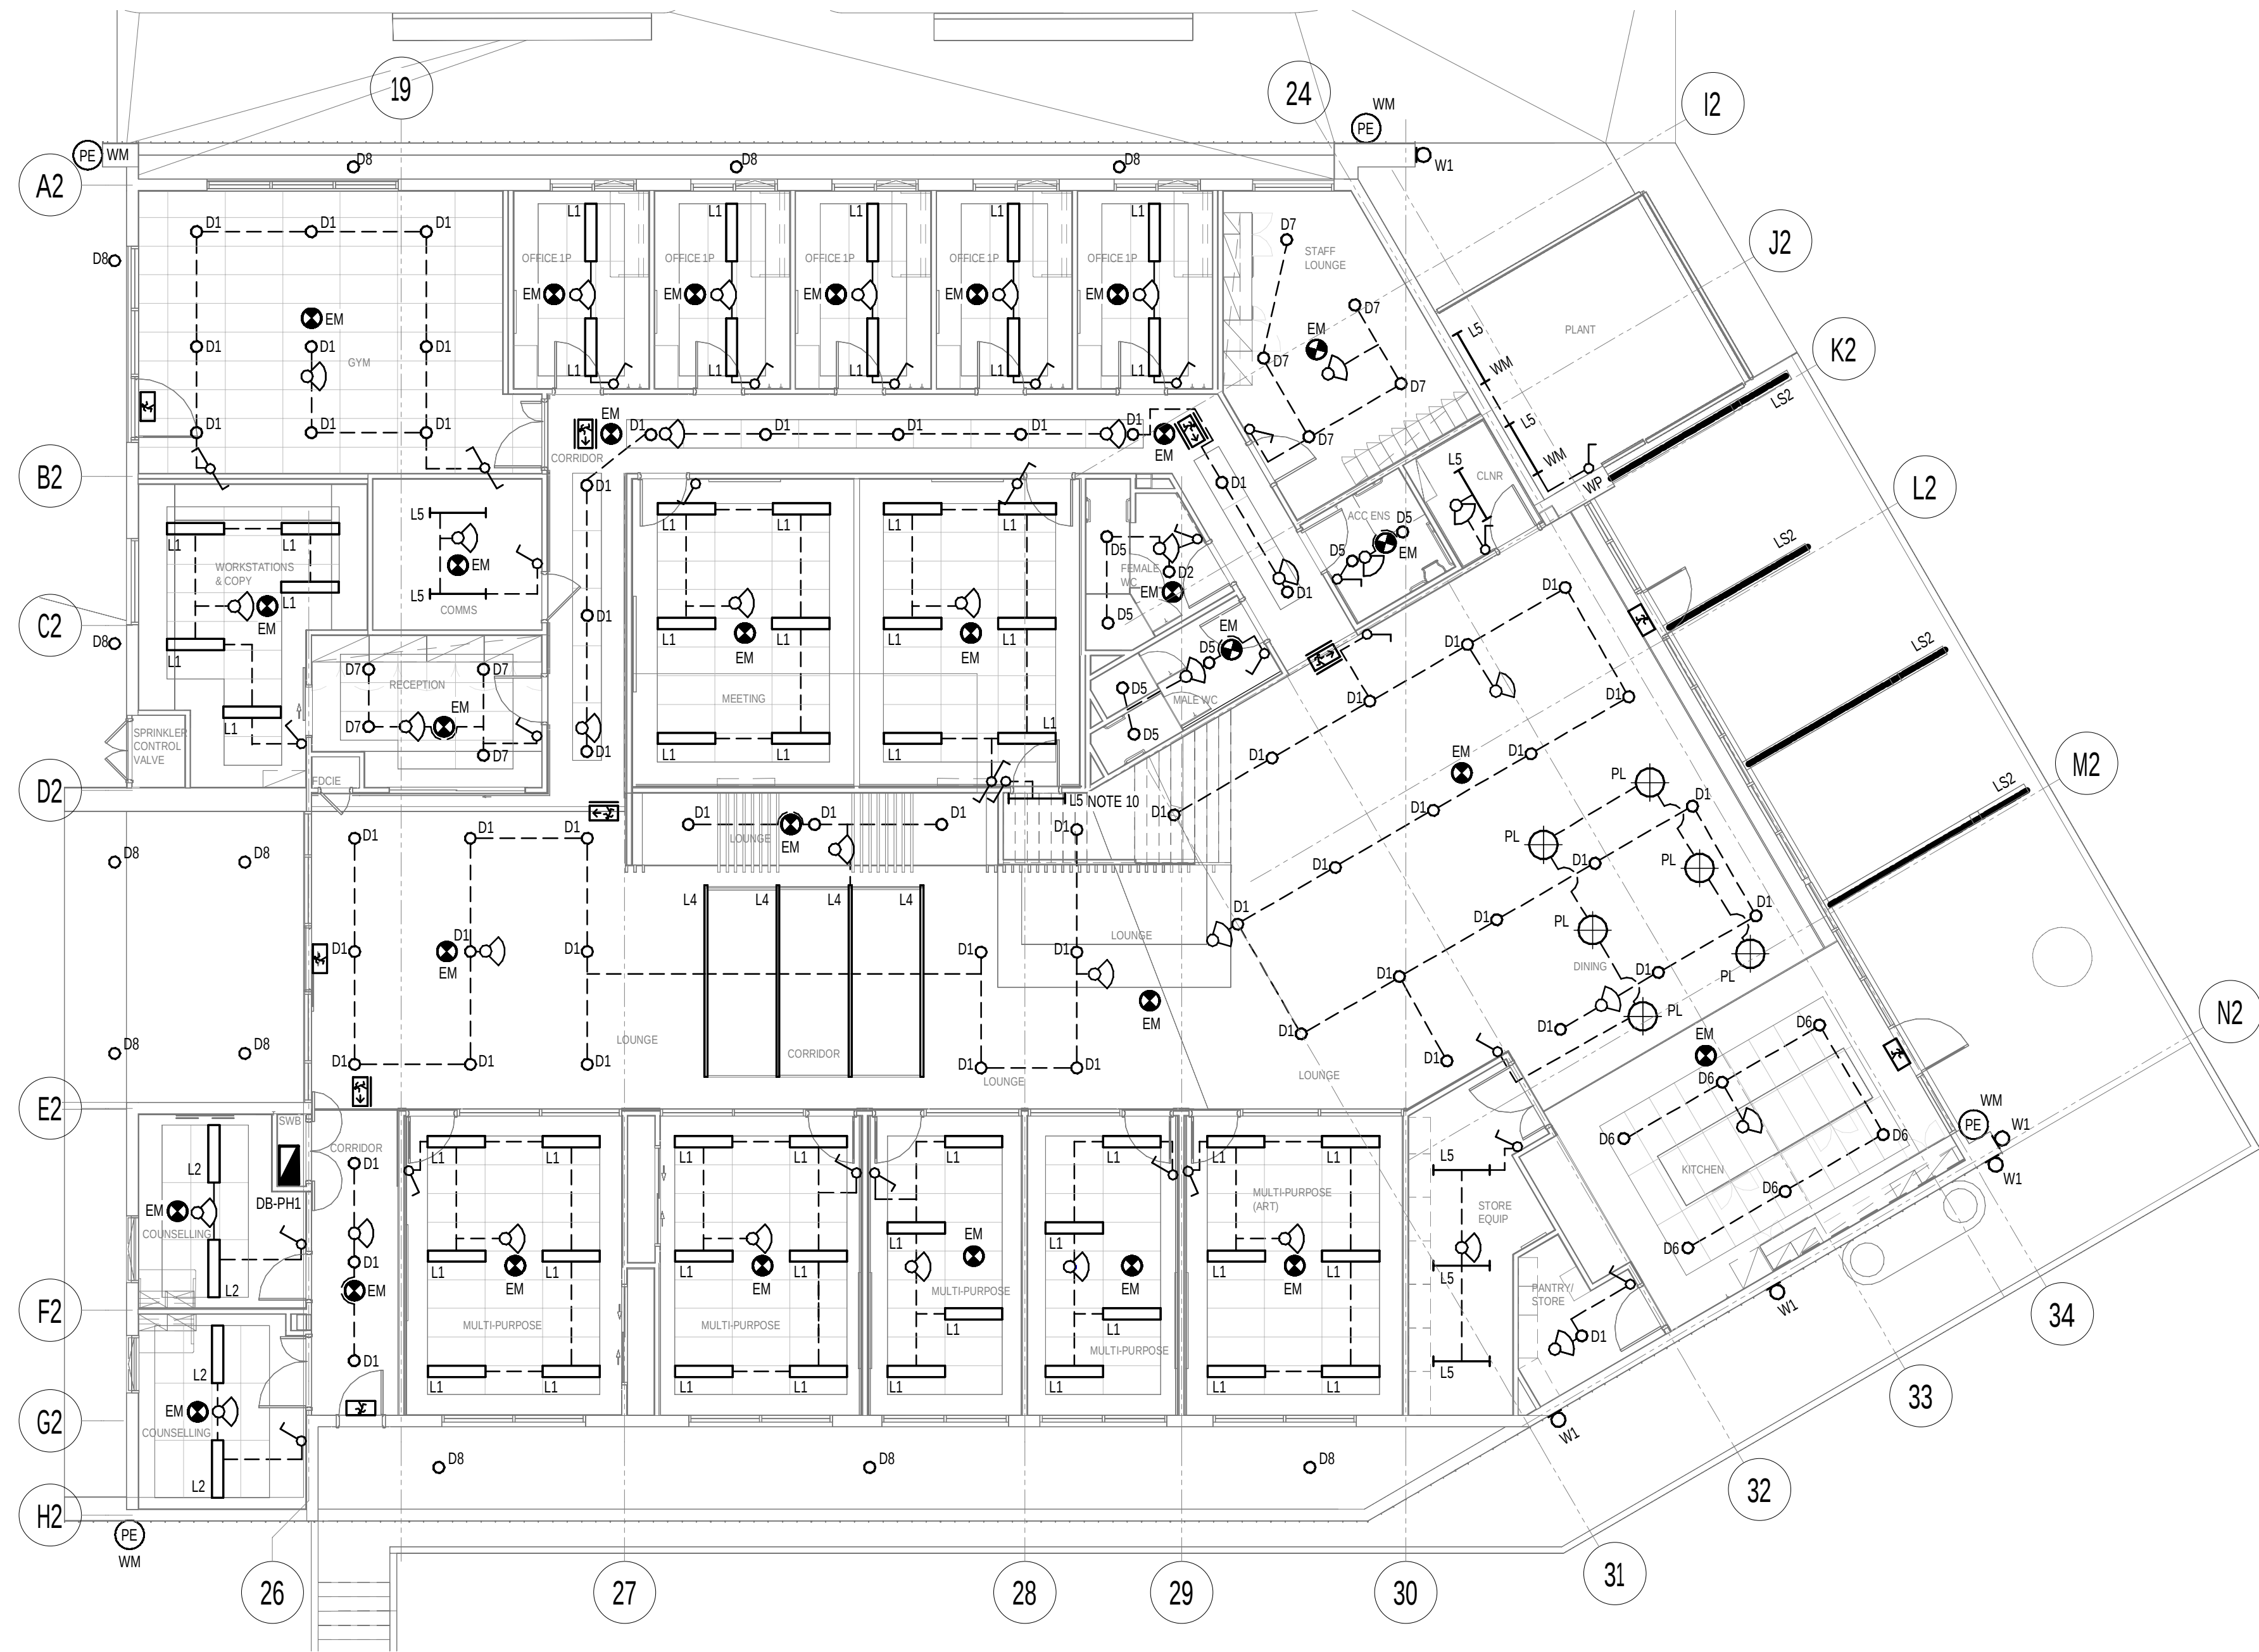

1 : 100

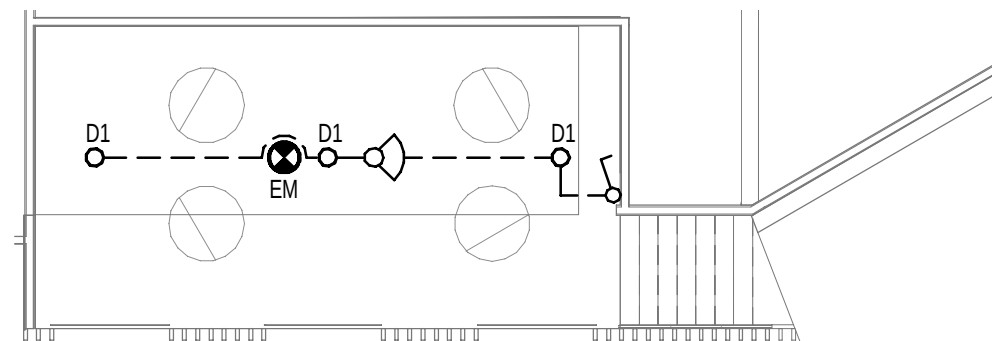

1 : 100

[illegible]

wsp

Level 2, 121 Marcus Clarke Street, Canberra ACT 2600
Tel: +61 2 6201 9600 / GPO Box 1551
<http://www.wsp.com>

CLIENT:



ARCHITECT:

PROJECT:

TITLE:	
--------	--

ELECTRICAL SERVICES
PALM HUB
LIGHTING LAYOUT

SCALE @ A1:

1:100

PROJECT NUMBER:
PS132290

DRAWING No:

CHECKED:

JJ

DRAWN: MAN

PROVED:

HH/KJE

TE: JANUARY 2023

 $\mathcal{V}_\infty$

© WSP Australia Pty Ltd