


KEYPLAN

NOTES

- FOR LEGEND AND SYMBOLS REFER TO DRAWING E001.
- ALL WORKS TO BE DONE IN ACCORDANCE TO AS/NZS 3000.
- THIS DRAWING TO BE READ IN CONJUNCTION WITH ALL OTHER ELECTRICAL DRAWINGS AND THE SPECIFICATION.
- COORDINATE FINAL LOCATIONS OF ALL LUMINAIRES AND CONTROLS WITH OTHER SERVICES ON SITE TO MECHANICAL, FIRE, HYDRAULICS AND ARCHITECTURAL SERVICES DRAWINGS AS NECESSARY.
- PROVIDE LUMINAIRES AND ASSOCIATED FINAL SUB-CIRCUIT WIRING AS REQUIRED TO COMPLETE THE INSTALLATION.
- PROVIDE COMBINED MCB AND 30mA RCD IN DISTRIBUTION BOARD FOR LIGHTING SUB-CIRCUITS OF 20A OR LESS. BALANCE THE LOAD EQUALLY ACROSS ALL THREE PHASES.
- INTERNAL LUMINAIRES TO BE CONTROLLED BY LOCAL LIGHT SWITCHES, SENSORS AND TIME CLOCK IN ACCORDANCE WITH THE BCA.
- CONNECT ALL EMERGENCY FITTINGS TO THE MANUAL DISCHARGE TEST FACULTY AT EACH DISTRIBUTION BOARD.
- EXTERNAL LIGHTS TO BE CONTROLLED BY PE CELL AND TIMECLOCK C/W AUTOMANUAL SWITCH LOCATED IN THE RELEVANT DISTRIBUTION BOARD.



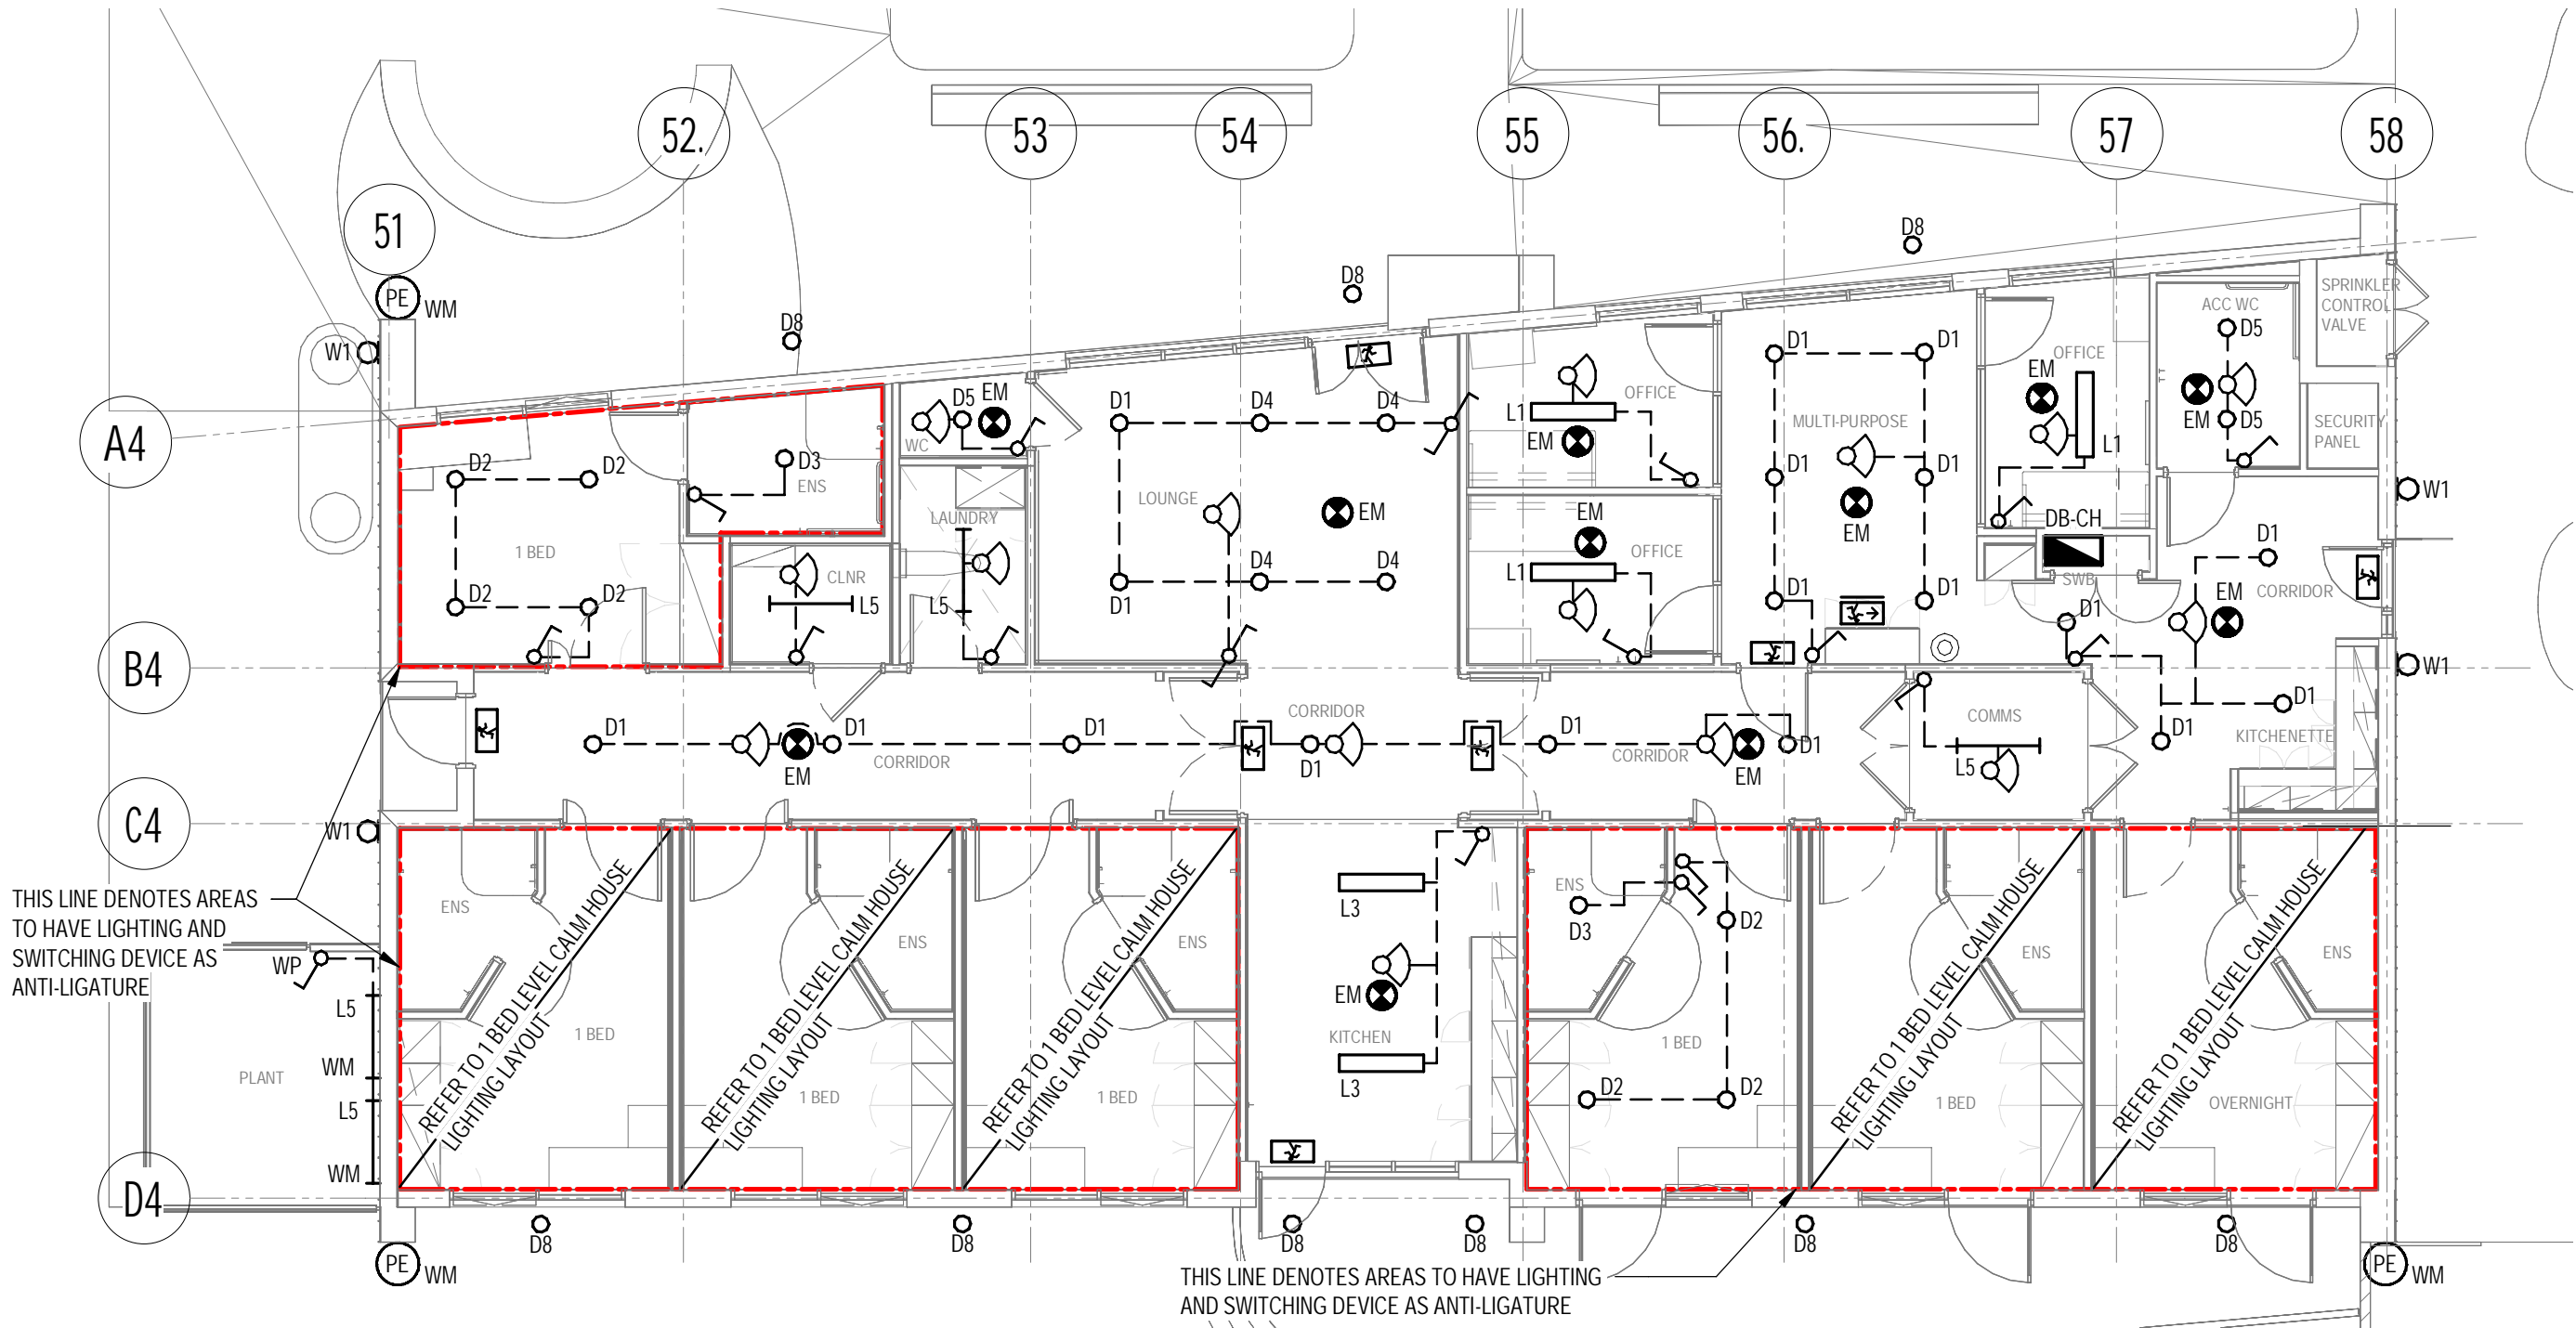


GROUND LEVEL - CALM HOUSE LIGHTING LAYOUT
1 : 100

P4	07.07.2023	NM	100% PSP			JJ	HH		
P3	28.04.2023	NM	80% PSP			JJ	HHKJE		
P2	03.03.2023	NM	50% PSP			SG	HH		
P1	03.02.2023	MAN	DRAFT 50% PSP			SG	HH		
REV	DATE	BY	DESCRIPTION			CHK	APP		
DRAWING STATUS:				PRELIMINARY					



Level 2, 121 Marcus Clarke Street, Canberra ACT 2600
Tel: +61 2 6201 9600 / GPO Box 1551
<http://www.wsp.com>

CLIENT:



ARCHITECT:


PROJECT:
WATSON HEALTH HUB

TITLE:
ELECTRICAL SERVICES
CALM HOUSE
LIGHTING LAYOUT

SCALE @ A1: 1:100	CHECKED: JJ	APPROVED: HHKJE
PROJECT NUMBER: PS132290	DRAWN: MAN	DATE: JANUARY 2023
DRAWING No: E120		REV: P4
© WSP Australia Pty Ltd		