


KEYPLAN

NOTES

- 1. FOR LEGEND AND SYMBOLS REFER TO DRAWING E001.
- 2. ALL WORKS TO BE DONE IN ACCORDANCE TO AS/NZS 3000.
- 3. THIS DRAWING TO BE READ IN CONJUNCTION WITH ALL OTHER ELECTRICAL DRAWINGS AND THE SPECIFICATION.
- 4. COORDINATE FINAL LOCATIONS OF ALL ELECTRICAL EQUIPMENT WITH OTHER SERVICES ON SITE TO MECHANICAL, FIRE, HYDRAULICS AND ARCHITECTURAL SERVICES DRAWINGS AS NECESSARY.
- 5. PROVIDE COMBINED MCB AND 30MA RCD IN DISTRIBUTION BOARD FOR ALL GENERAL POWER SUB-CIRCUITS OF 20A OR LESS. BALANCE THE LOAD EQUALLY ACROSS ALL THREE PHASES.
- 6. PROVIDE POWER, DATA AND MATV OUTLET FOR TELEVISION SET.
- 7. WAP LOCATIONS ARE INDICATIVE ONLY. FINAL REQUIREMENTS TO BE CONFIRMED BY CONTRACTOR.
- 8. PROVIDE SINGLE DATA OUTLET IN CEILING FOR ALL EXTERNAL CCTV.
- 9. INFRASTRUCTURE CONNECTIVITY REQUIREMENTS FOR FUTURE PATIENT INFORMATION AND ENTERTAINMENT SYSTEM (PIES). FINAL REQUIREMENTS TO BE CONFIRMED.

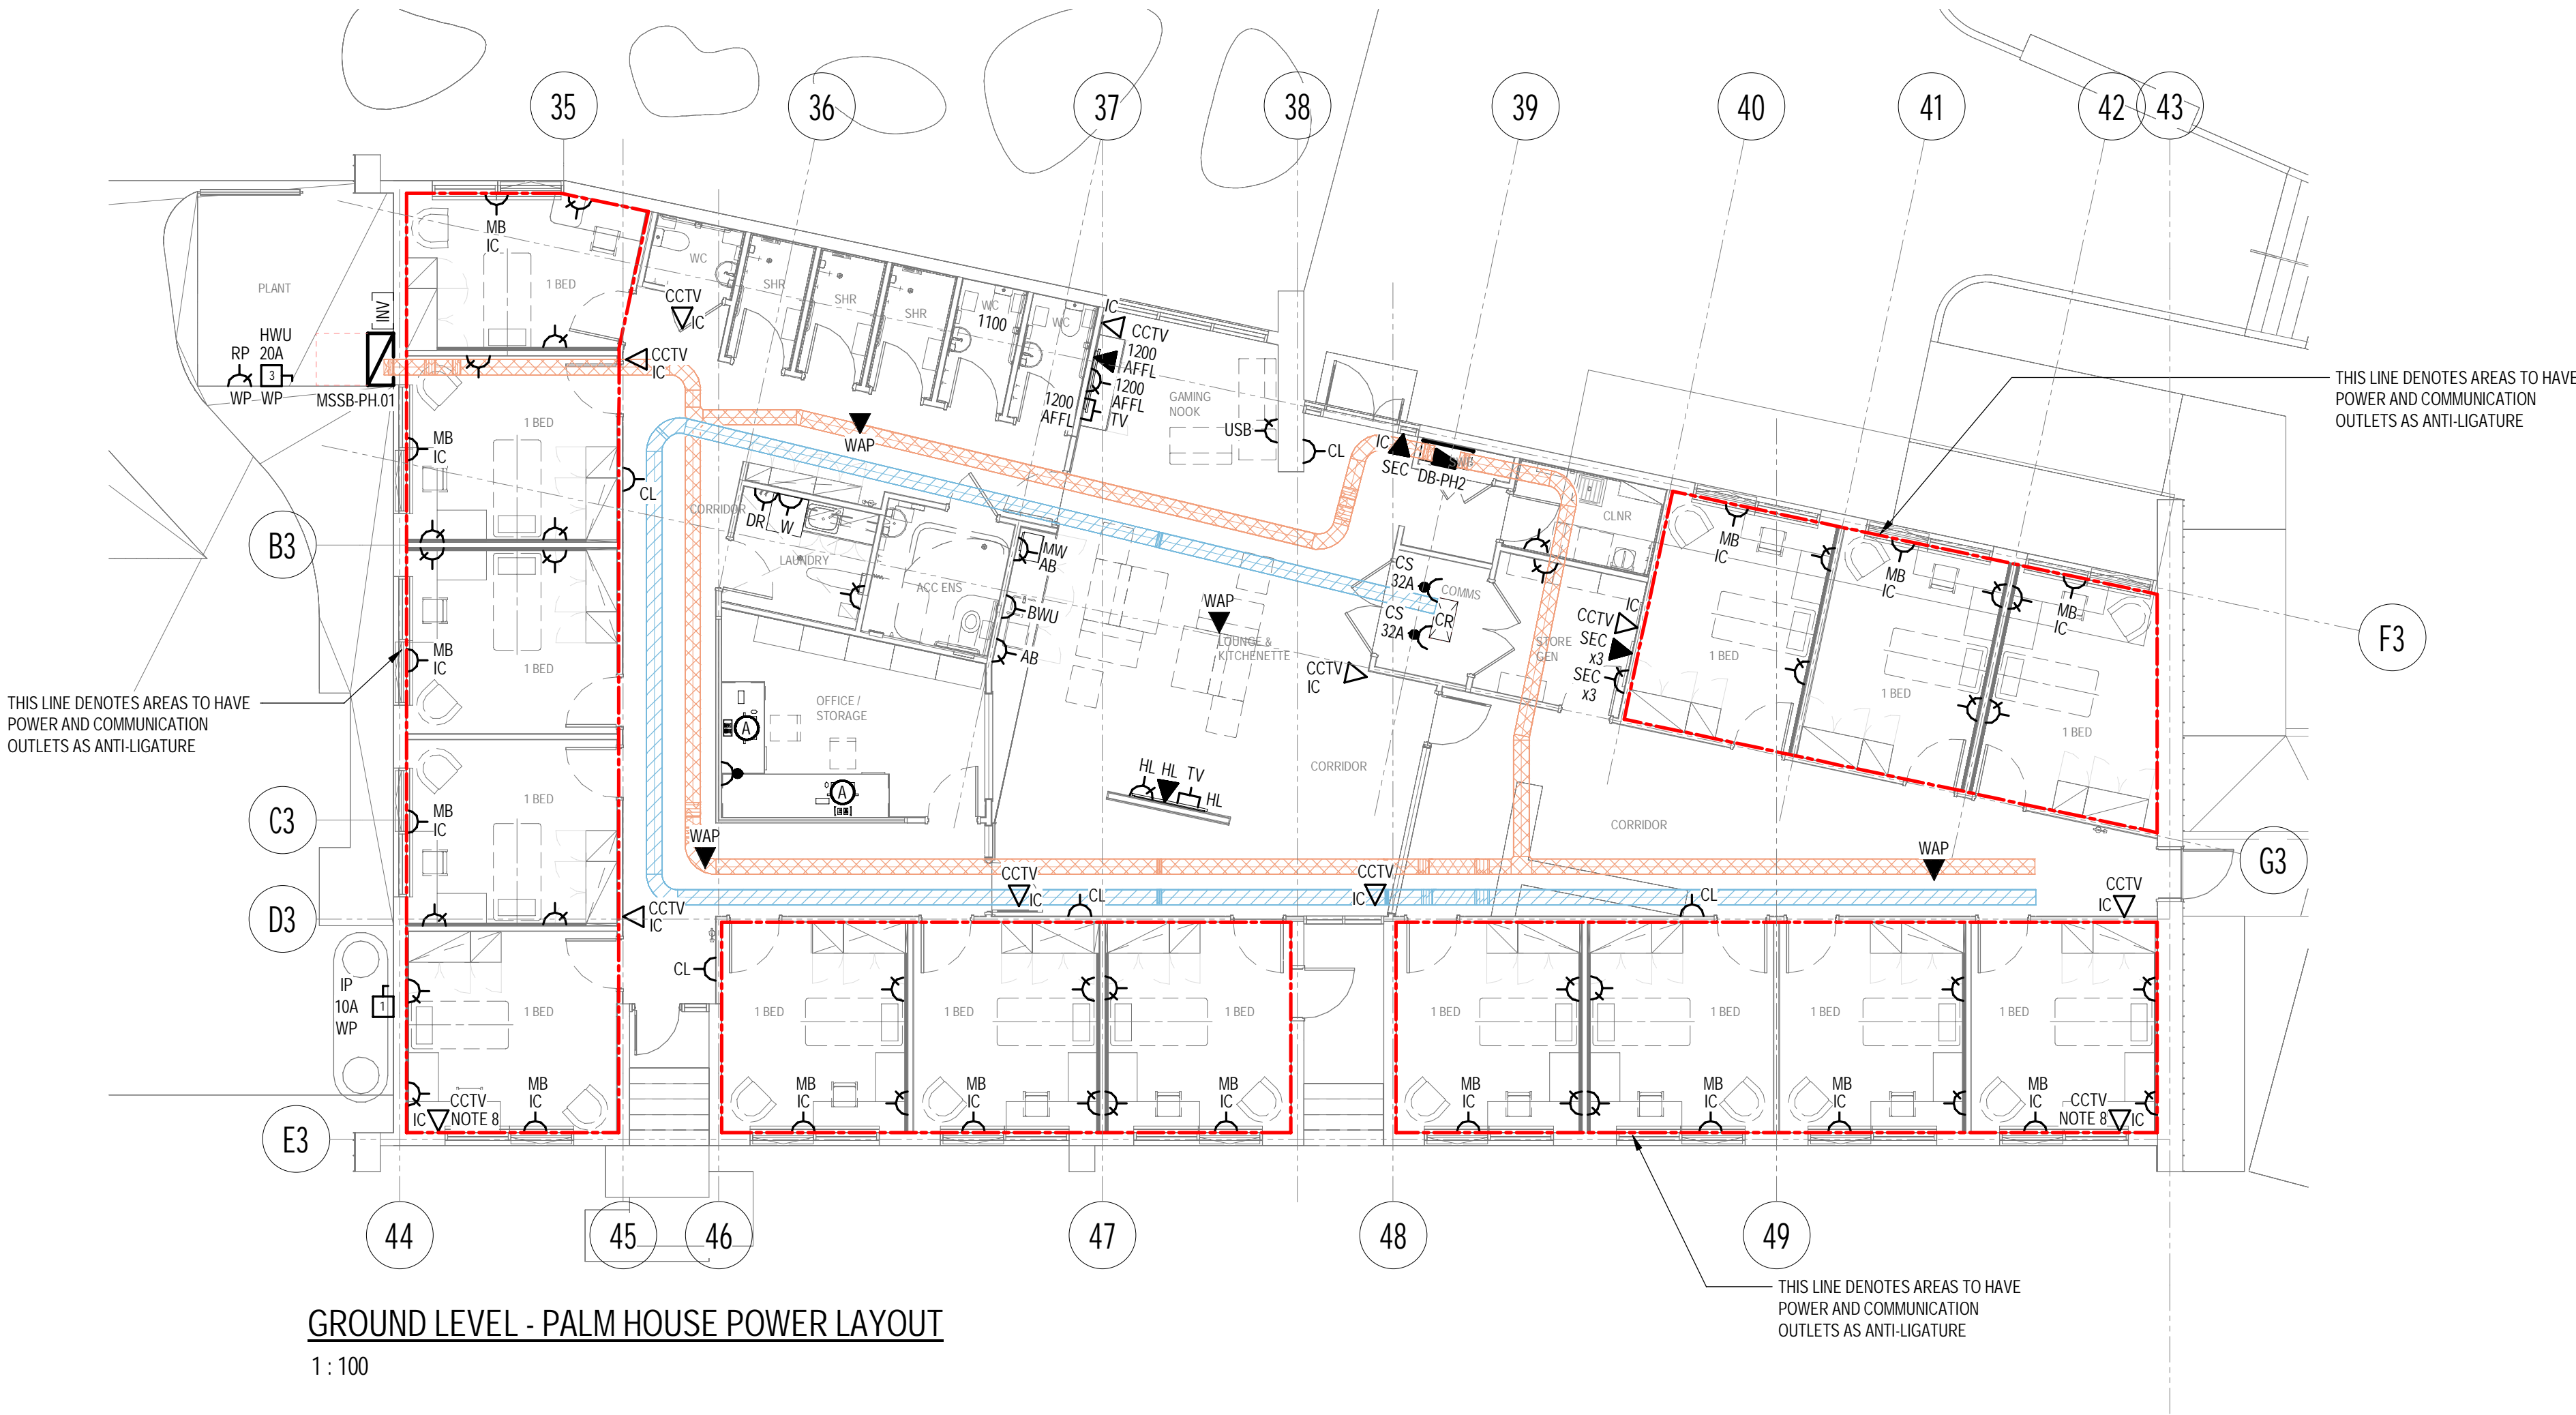

GROUND LEVEL - PALM HOUSE POWER LAYOUT
1:100

DRAWING CREATED IN REVIT.

REV	DATE	BY	DESCRIPTION	CHK	APP
P4	07.07.2023	NM	100% PSP	JJ	HH
P3	28.04.2023	NM	80% PSP	JJ	HHKJE
P2	03.03.2023	NM	50% PSP	SG	HH
P1	03.02.2023	MAN	DRAFT 50% PSP	SG	HH
DRAWING STATUS: PRELIMINARY					



Level 2, 121 Marcus Clarke Street, Canberra ACT 2600
Tel: +61 2 6201 9600 / GPO Box 1551
<http://www.wsp.com>

CLIENT:



ARCHITECT:



PROJECT:

WATSON HEALTH HUB

TITLE:

ELECTRICAL SERVICES
PALM HOUSE
POWER AND COMMUNICATION LAYOUT

SCALE @ A1:	CHECKED:	APPROVED:
1:100	JJ	HHKJE
PROJECT NUMBER:	DRAWN:	DATE:
PS132290	MAN	JANUARY 2023
DRAWING No:		REV:
E230		P4
© WSP Australia Pty Ltd		